


GENERAL NOTES


1. AT ALL LOCATIONS OPEN TO STRUCTURE ABOVE, EXTEND ALL WALLS, (INCLUDING ALL STUD FRAMING, GYPSUM BOARD, INSULATION & CMU WHERE APPLICABLE TO THE METAL ROOF DECK ABOVE.
2. PROVIDE WATER-PROOFING MEMBRANE SYSTEM ON FLOOR OF MEZZANINE LEVEL. RUN UP WALLS 6" BEHIND GYP. BD. SHEATHING. TYPICAL.

KEYNOTES

- 1 CONCRETE FILLED PIPE BOLLARD
- 2 TRENCH DRAIN
- 3 TRENCH DRAIN - COORDINATE W/ PLUMBING DRAWINGS & 5/S5.4
- 4 6" STEP - PAINT YELLOW
- 5 STRUCTURAL STL - SEE STRUCTURAL DWG.
- 6 MECHANICAL ROOM MEZZANINE ACCESS LADDER - SEE DETAIL A4/A5.12
- 7 FIRE EXTINGUISHER CABINET - SEMI-RECESSED
- 8 FIRE EXTINGUISHER CABINET - SURFACE MTD
- 9 ROOF DRAIN OVERFLOW DISCHARGE
- 10 HOSE BIB

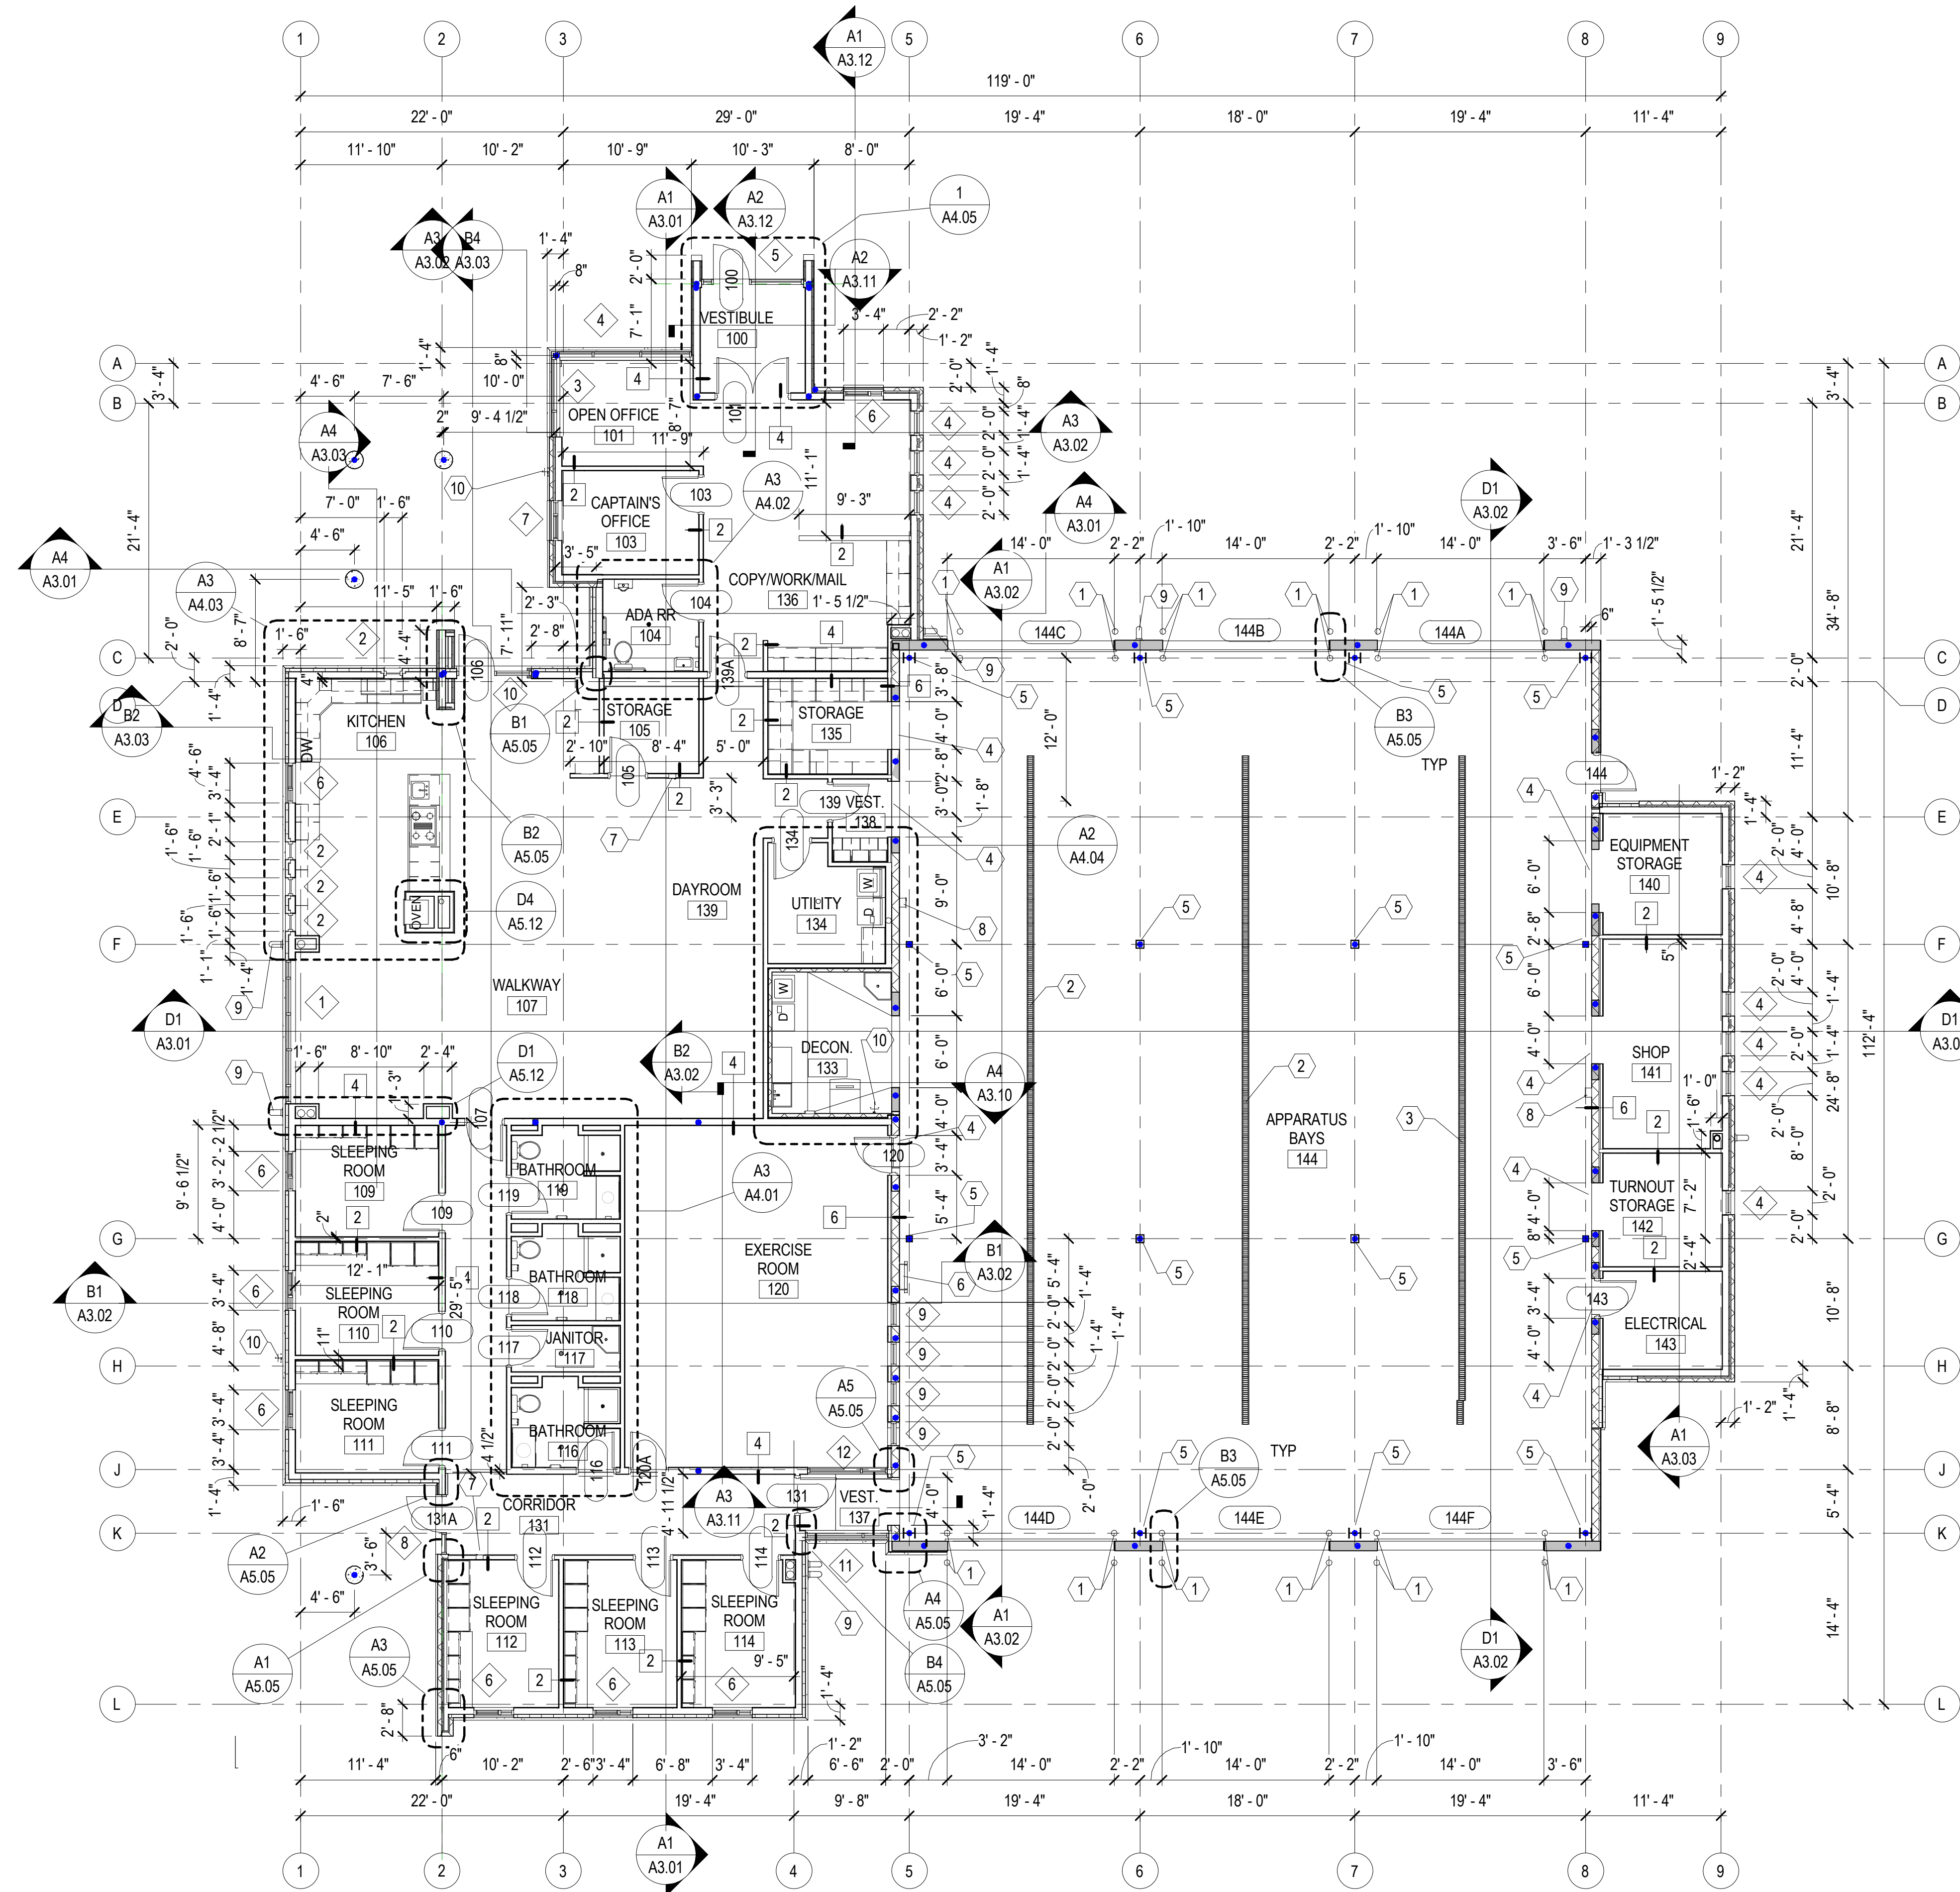

FIRST FLOOR

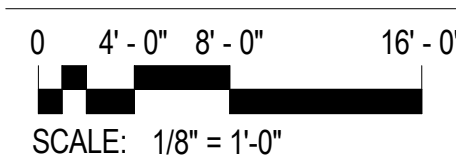

**PARK CITY FIRE
DISTRICT
STATION #33**
730 BITNER ROAD
SNYDERVILLE, UTAH

©2007 MHTN ARCHITECTS, INC.
Drawings, written material, and design concepts shall not be used or reproduced in whole or part in any form or format without prior written consent of MHTN Architects, Inc. Do not scale drawings. Use given dimensions only. If not shown, verify correct dimensions with the Architect. Contractor shall check and verify all dimensions and conditions at job site.

SEAL

MHTN PROJECT NO. 2008573

DRAWN BY: Author CHECKED BY: Checker

ISSUED:

NO.	DATE	DESCRIPTION

CONTRACTOR TO VERIFY DRAWINGS IN FIELD USE REFLECT LAST REVISION DATE:

NO.	DATE	DESCRIPTION

SHEET NAME
**FIRST FLOOR
PLAN**

CONSTRUCTION SET
APRIL 4, 2011

SHEET NUMBER

A1.01

GENERAL NOTES


1. REFER TO MECHANICAL DRAWINGS FOR PLUMBING FIXTURE SPECIFICATIONS.
2. FLOORING TO EXTEND UNDER ALL APPLIANCES, EQUIPMENT AND KNEE SPACES.

KEYNOTES

- 1 LIMESTONE THRESHOLD
- 2 CARPET TO CONCRETE TRANSITION, PROVIDE VINYL REDUCER STRIP
- 3 RUBBER TILE TO CARPET, PROVIDE VINYL REDUCER STRIP
- 4 FULL HEIGHT MIRROR, MOUNTED ABOVE BASE, BUTT JOINTS AND POLISHED EDGES

LEGEND - FINISH MATERIALS

	F1 - CARPET
	F2 - WALK-OFF CARPET
	F3 - 7"x48" VYNIL PLANK
	F5 - 12" X 12" TILE
	F6 - 6" X 6" TILE
	F7 - SPORT FLOORING
	CONCRETE

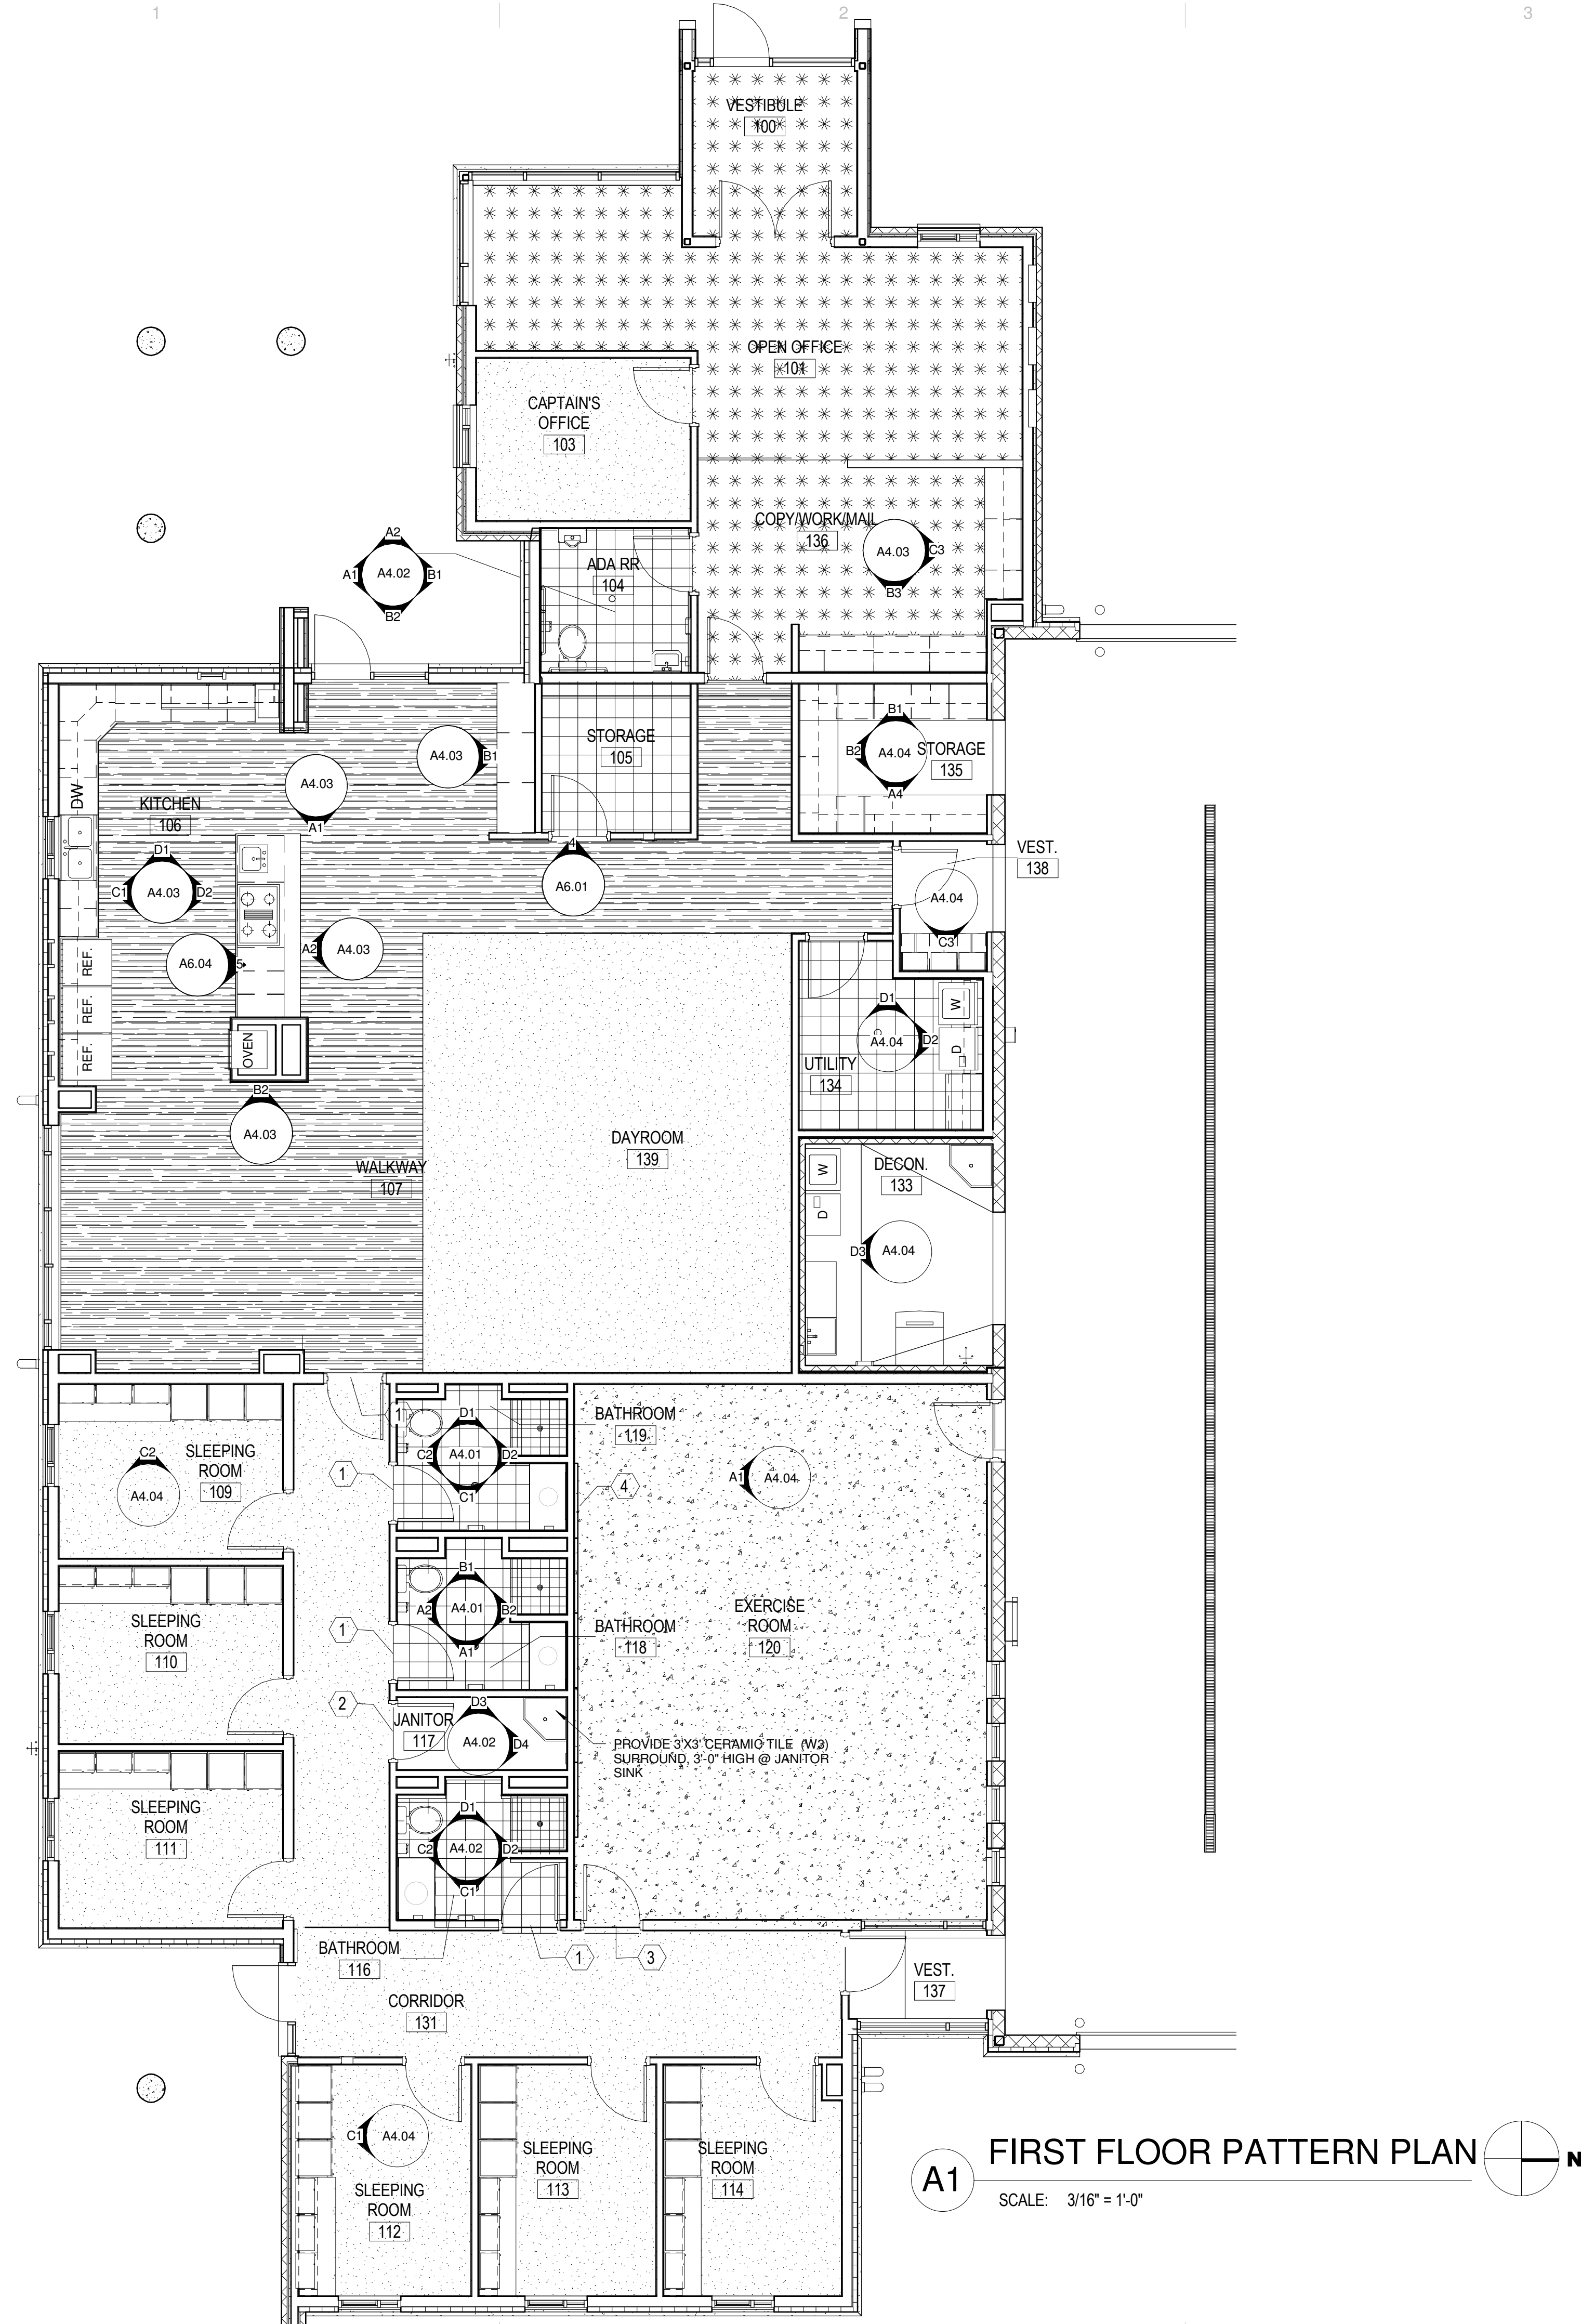

A1 FIRST FLOOR PATTERN PLAN
SCALE: 3/16" = 1'-0"

PARK CITY FIRE DISTRICT STATION #33
730 BITNER ROAD
SNYDERVILLE, UTAH

©2007 MHTN ARCHITECTS, INC.
Drawings, written material, and design concepts shall not be used or reproduced in whole or part in any form or format without prior written consent of MHTN Architects, Inc. Do not scale drawings. Use given dimensions only. If not shown, verify correct dimensions with the Architect. Contractor shall check and verify all dimensions and conditions at job site.

SEAL

MHTN PROJECT NO. 2008573

DRAWN BY: Author CHECKED BY: Checker

ISSUED:

NO.	DATE	DESCRIPTION

CONTRACTOR TO VERIFY DRAWINGS IN FIELD USE REFLECT LAST REVISION DATE:

NO.	DATE	DESCRIPTION

FLOOR PATTERN & INTER. ELEV.

CONSTRUCTION SET
APRIL 4, 2011

SHEET NUMBER

A4.10

